


### INDEX OF DRAWINGS

- A1 PLOT PLAN & LIST OF DRAWINGS
- A2 MAIN FLOOR & BASEMENT PLAN
- A3 EXTERIOR ELEVATIONS
- A4 LONGITUDINAL BUILDING SECTIONS
- A5 TRANSVERSE BUILDING SECTIONS
- M1 MECHANICAL PLANS
- M2 MECHANICAL ROOM
- E1 ELECTRICAL PLOT PLAN
- E2 LIGHTING FLOOR PLANS
- E3 POWER FLOOR PLAN
- E4 FIXTURE SCHEDULE
- S1 BASEMENT & FOUNDATION SCHEMES
- S2 FLOOR FRAMING SCHEME "I"
- S3 FLOOR FRAMING SCHEME "II"
- S4 ROOF FRAMING SCHEME "I" & "II"

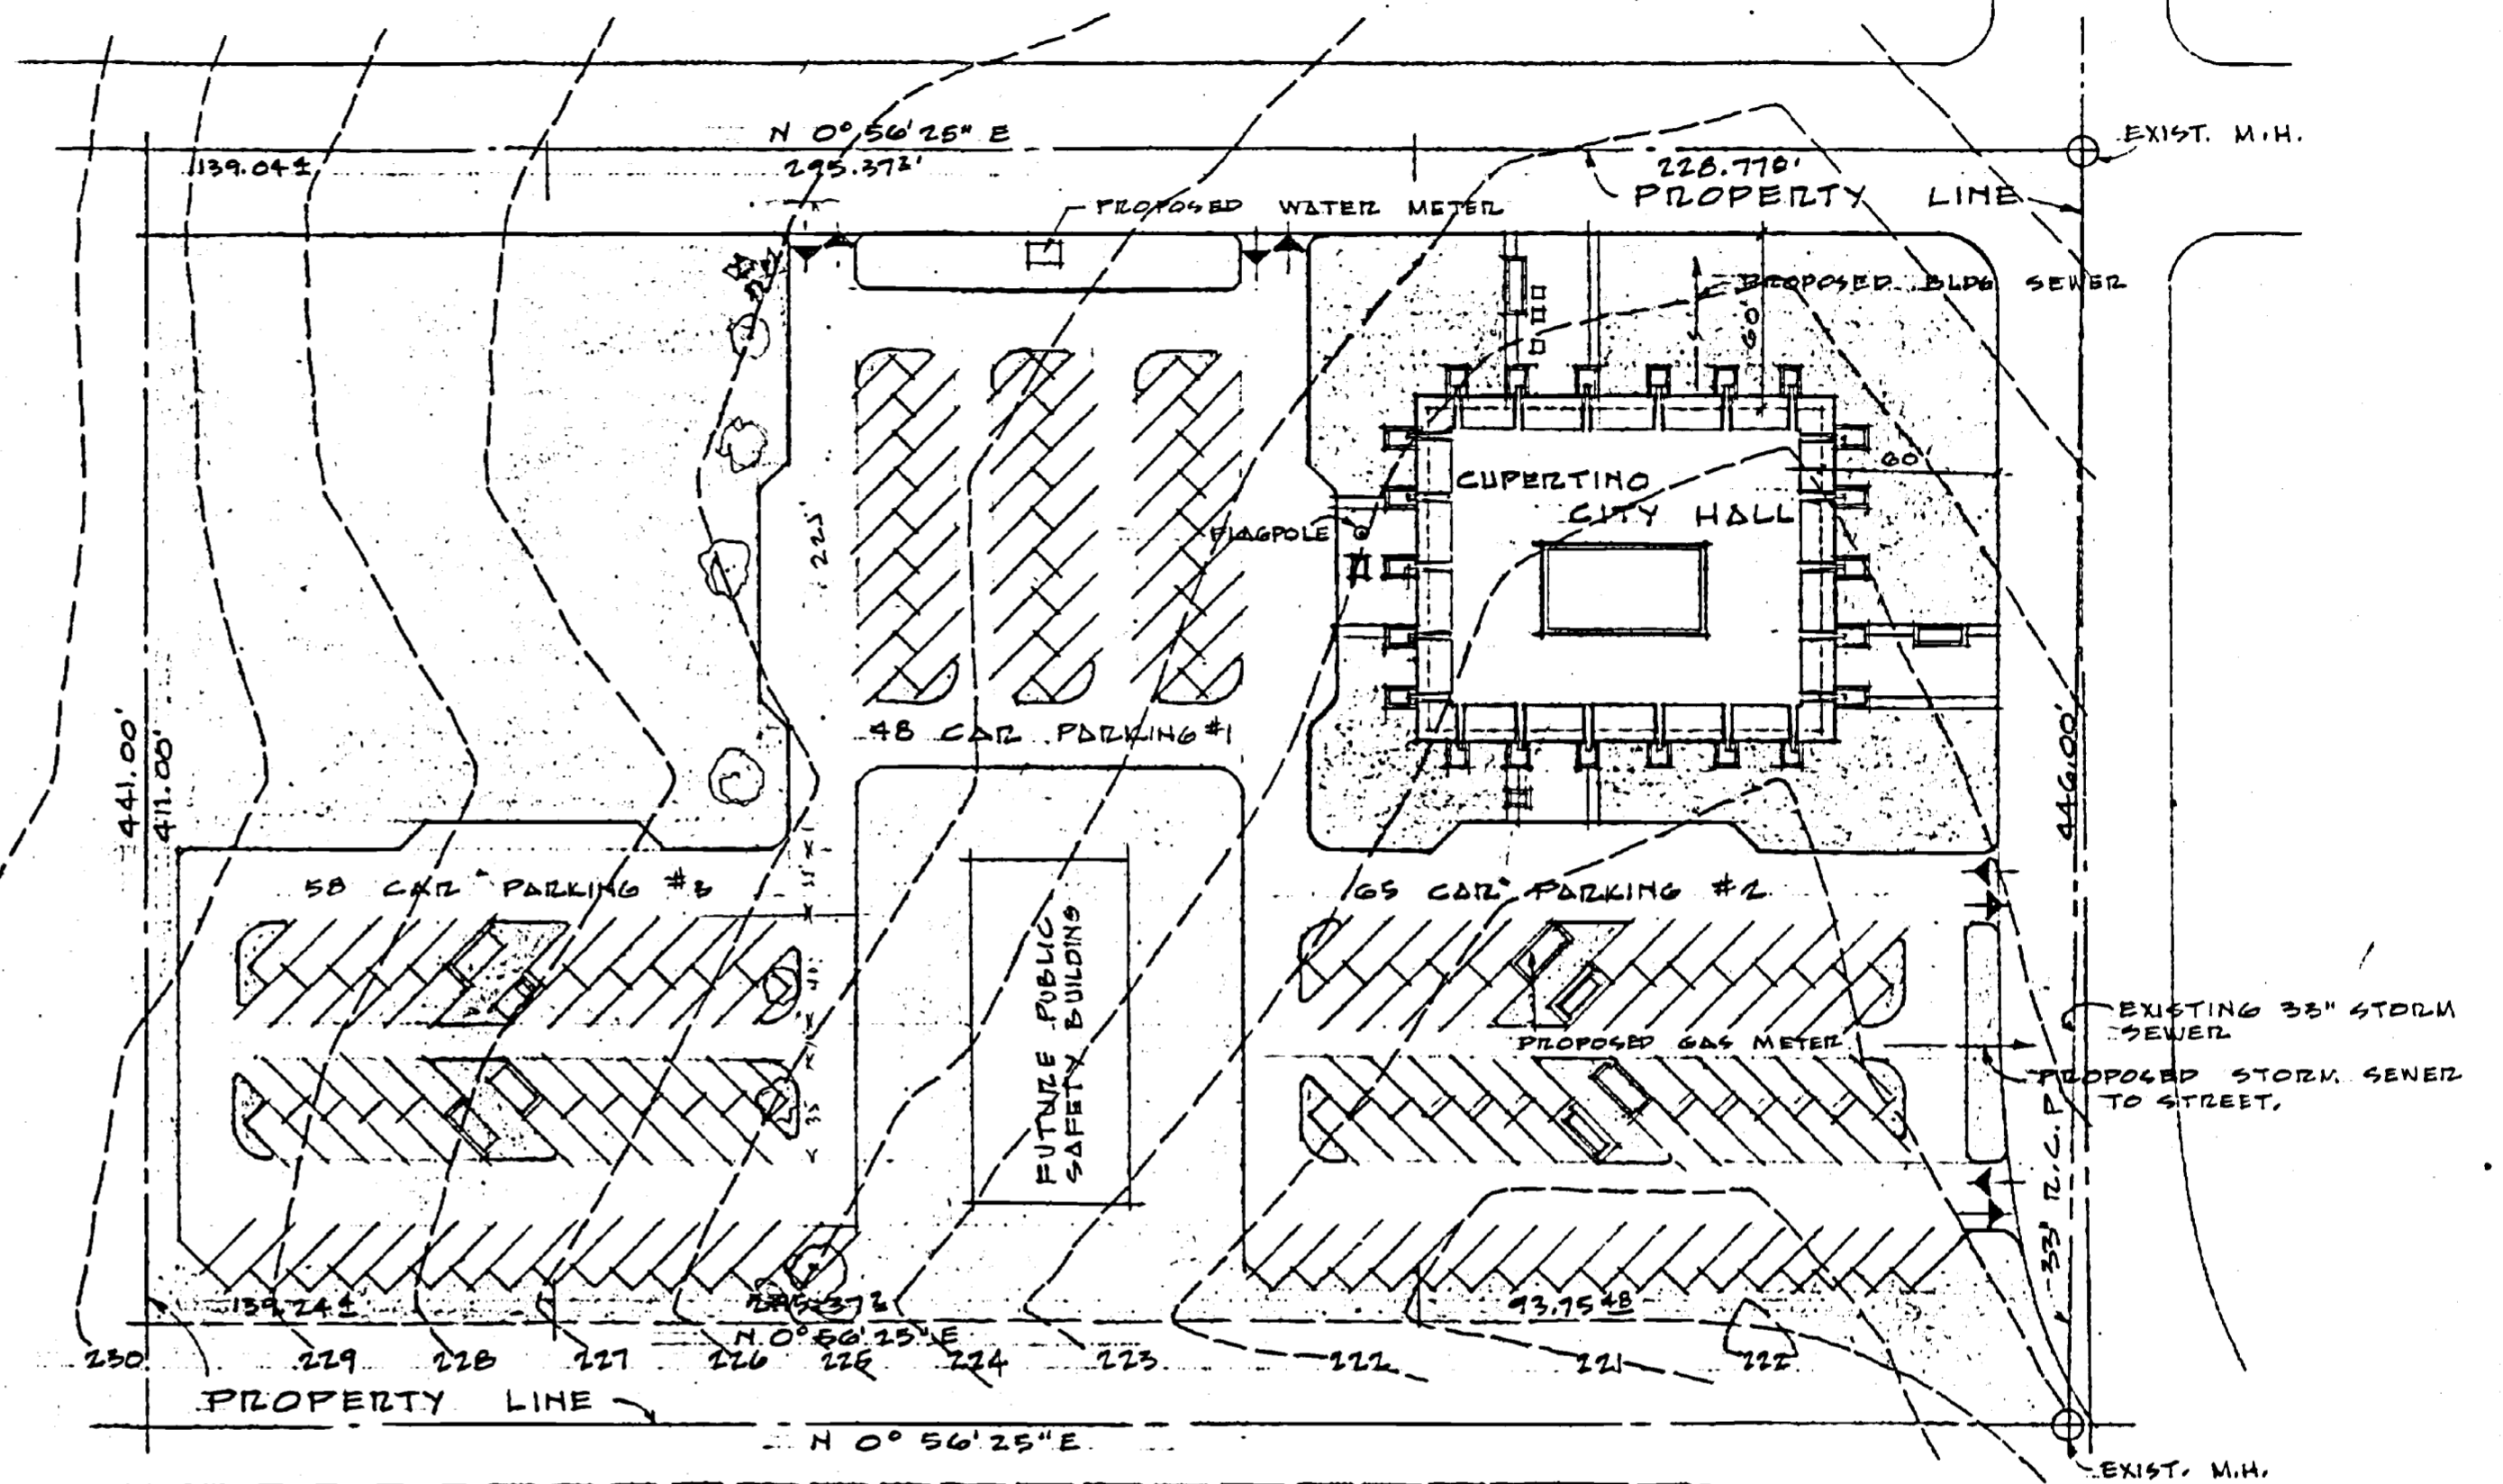

**PLOT PLAN**  
 SCALE: 1" = 60.0'  
 PLOT PLAN CONTOURS AND BOUNDARIES REPRODUCED FROM PLAT SURVEY DRAWING FURNISHED APRIL 1963 MAKAY & SOMPS CIVIL ENGINEERS 1003 W. EL CAMINO REAL SUNNYVALE CALIFORNIA

**CUPERTINO CITY HALL**  
 S.E. CORNER OF RODRIGUES & TORRE, CUPERTINO, CALIFORNIA

**PLOT PLAN & INDEX OF DRAWINGS**

WILFRED E. BLESSING A.I.A.  
 ARCHITECT & LANDSCAPE ARCHITECT



3593 STEVENS CREEK BLVD.  
 SAN JOSE 28, CALIFORNIA

DRAWN: ILM  
 CHECKED:  
 DATE: FEB. 5, 1968


**A1**

10300 Torre-Ave



PLANT LIST INCLUDED IN CONTRACT			PLANT LIST NOT IN CONTRACT		
AMT.	NAME	COMMON NAME	AMT.	NAME	COMMON NAME
TREES					
0	CINNAMOMUM CAMPHORA	CAMPHERE TREES	20	COEYBASSIA OFFICINALIS	CHERRY BLOSSOM
10	LIQUIDAMBAR	SWEET GUM	1	PETUNIAS	
1	JUNIPERUS HORIZONTALIS	CREeping JUNIPER	1		
1	JUNIPERUS SABINA	TAMARISK JUNIPER			
1	DAHPHILEPIS INDICA	PINK INDIA HAWTHORNE			
GROUND COVERS					
1	HYPERICUM CALYCINUM	AARON'S BEARD			

PLANT LIST NOT IN CONTRACT			PLANT LIST NOT IN CONTRACT		
AMT.	NAME	COMMON NAME	AMT.	NAME	COMMON NAME
TREES					
1	ACACIA MELANOXYLON	BLACKWOOD ACACIA	1	DAHPHILEPIS INDICA	PINK INDIA HAWTHORNE
1	CESTRAEUS LANCEOLATUS	CAMPHERE TREES	1	HYPERICUM CALYCINUM	AARON'S BEARD
1	CINNAMOMUM CAMPHORA	CAMPHERE TREES	1	TEACHLSPERMIUM	SWEET JASMINE
1	CESTRAEUS LANCEOLATUS	CAMPHERE TREES			
1	LIQUIDAMBAR	SWEET GUM			
1	BUCALYPTUS CITRUS	LEMON SCENTED GUM			
1	LIQUIDAMBAR	SWEET GUM			
1	NEGIUM CLEANDER	CLEANDER			

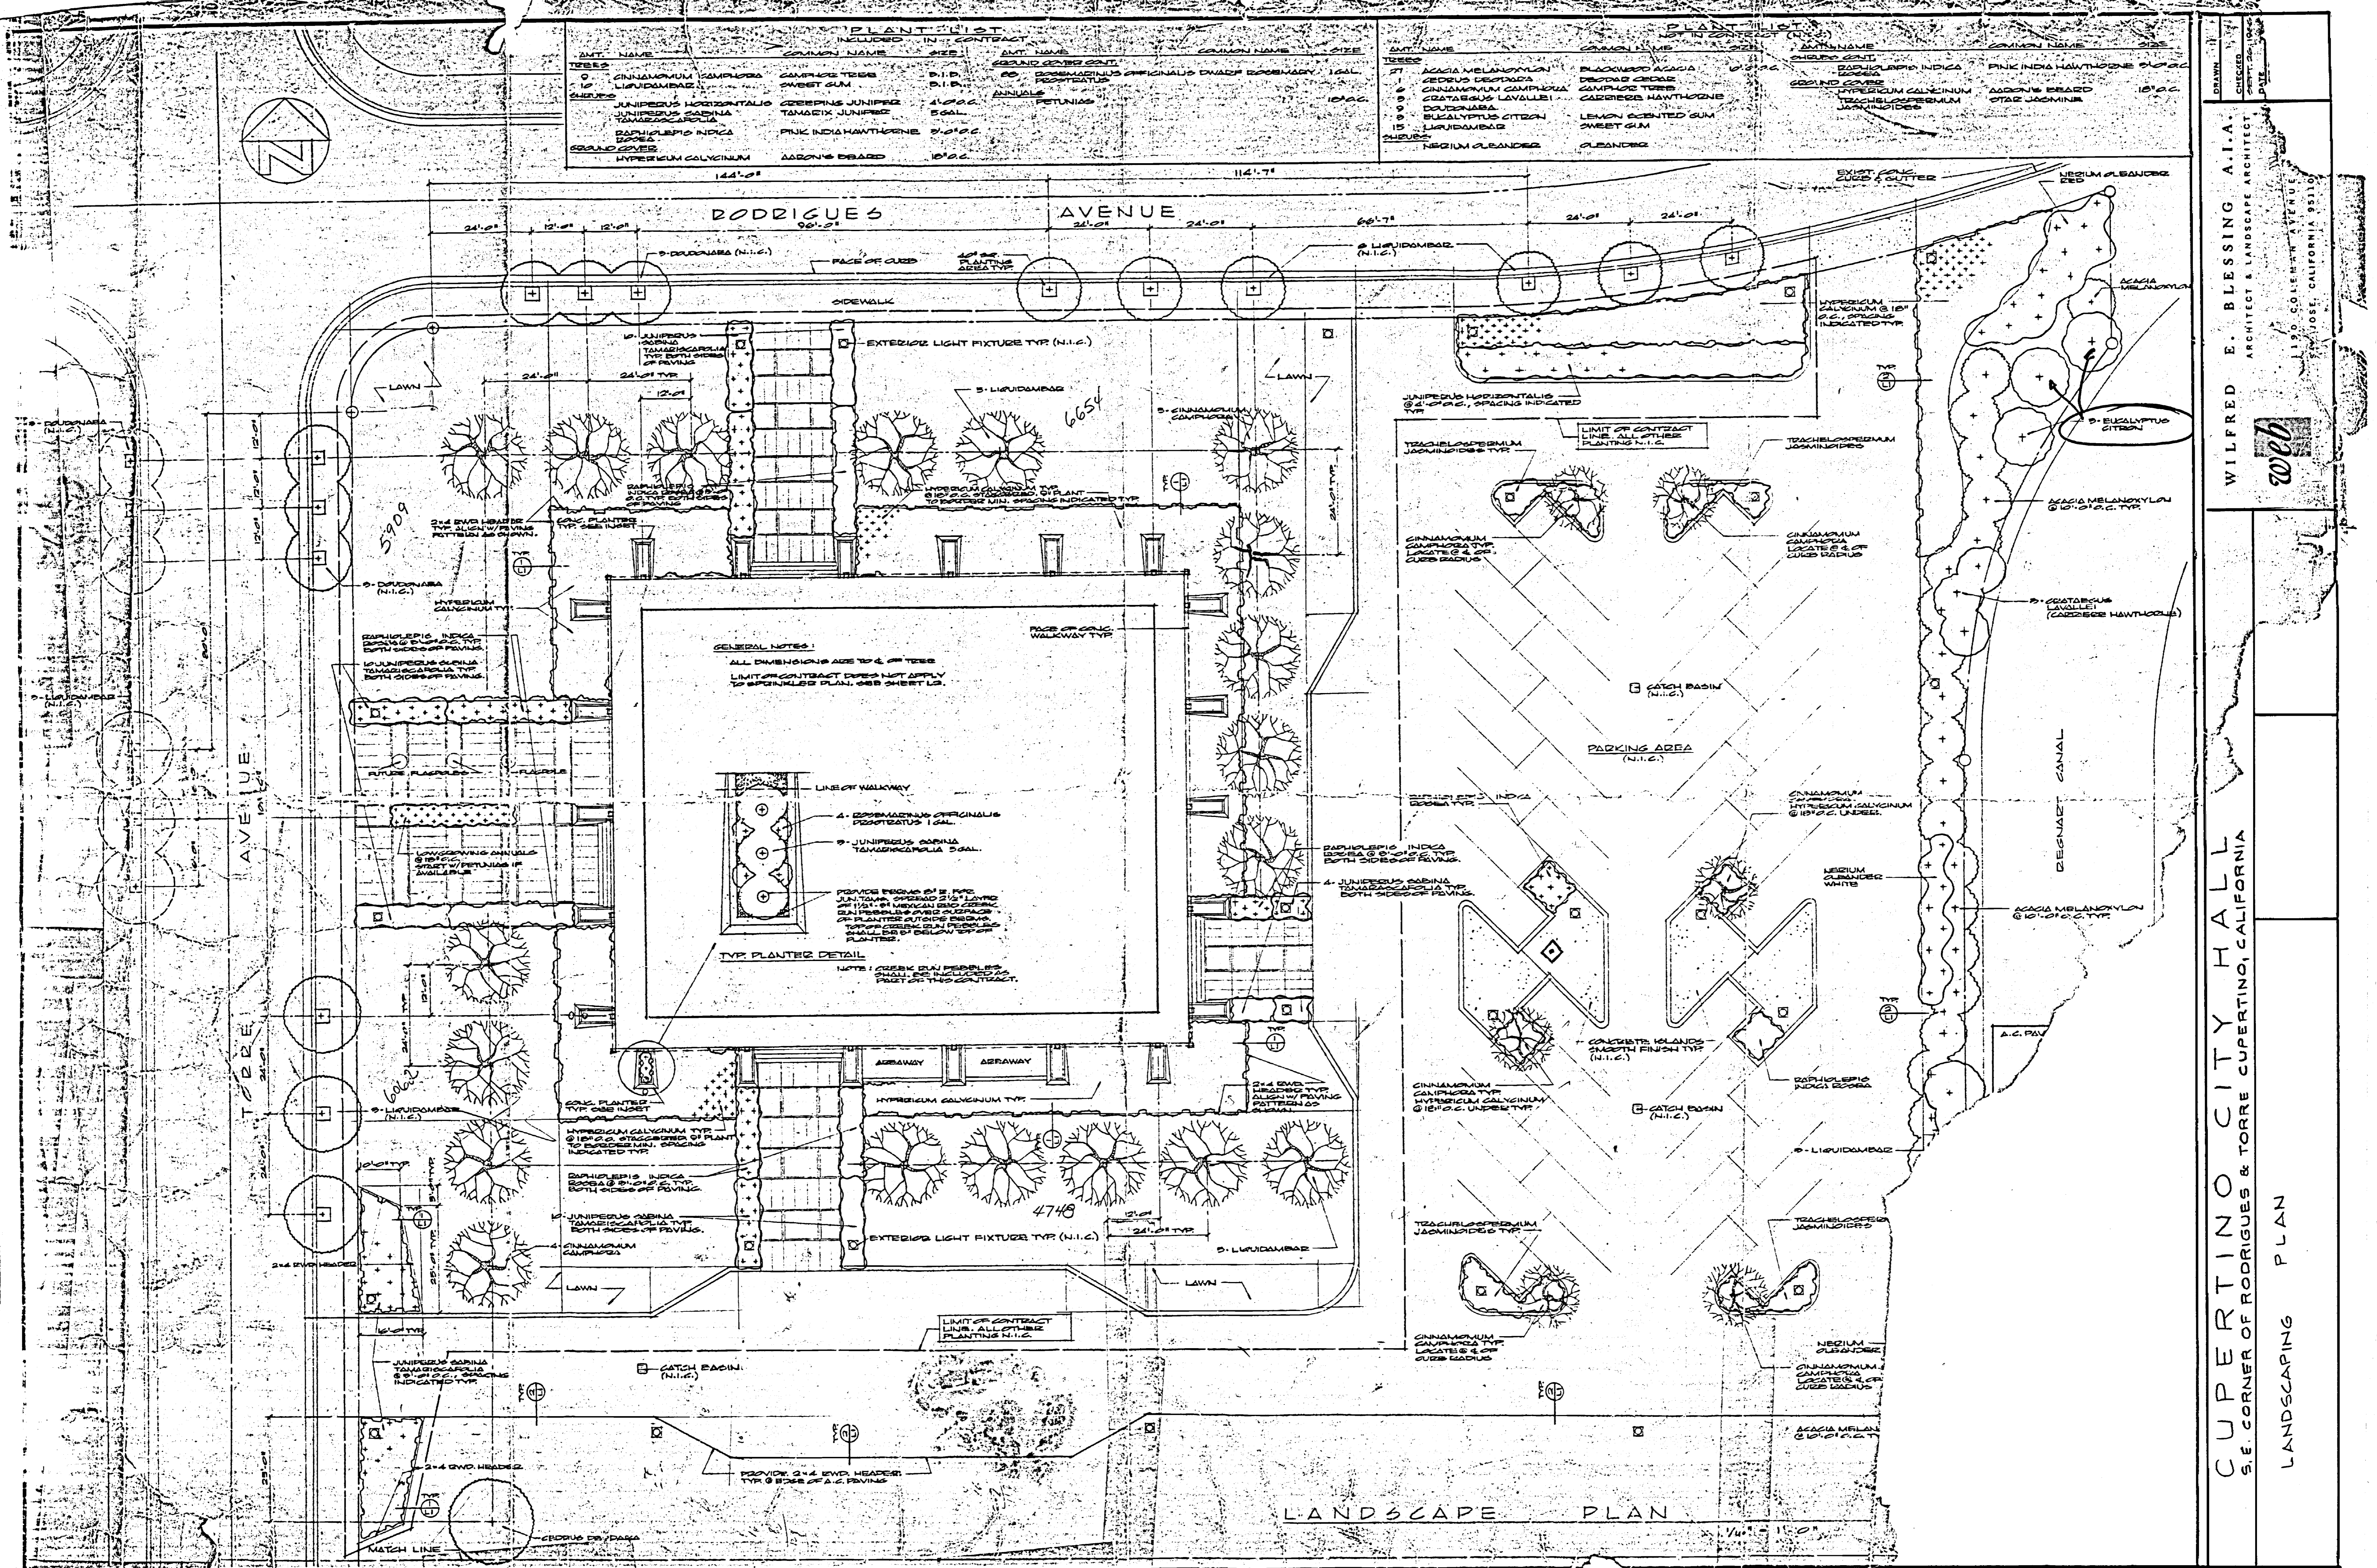


LANDSCAPE PLAN

WILFRED E. BLESSING A.I.A.  
 ARCHITECT & LANDSCAPE ARCHITECT  
 1190 COLLEEN AVENUE  
 SAN JOSE, CALIFORNIA 95128

LANDSCAPING PLAN



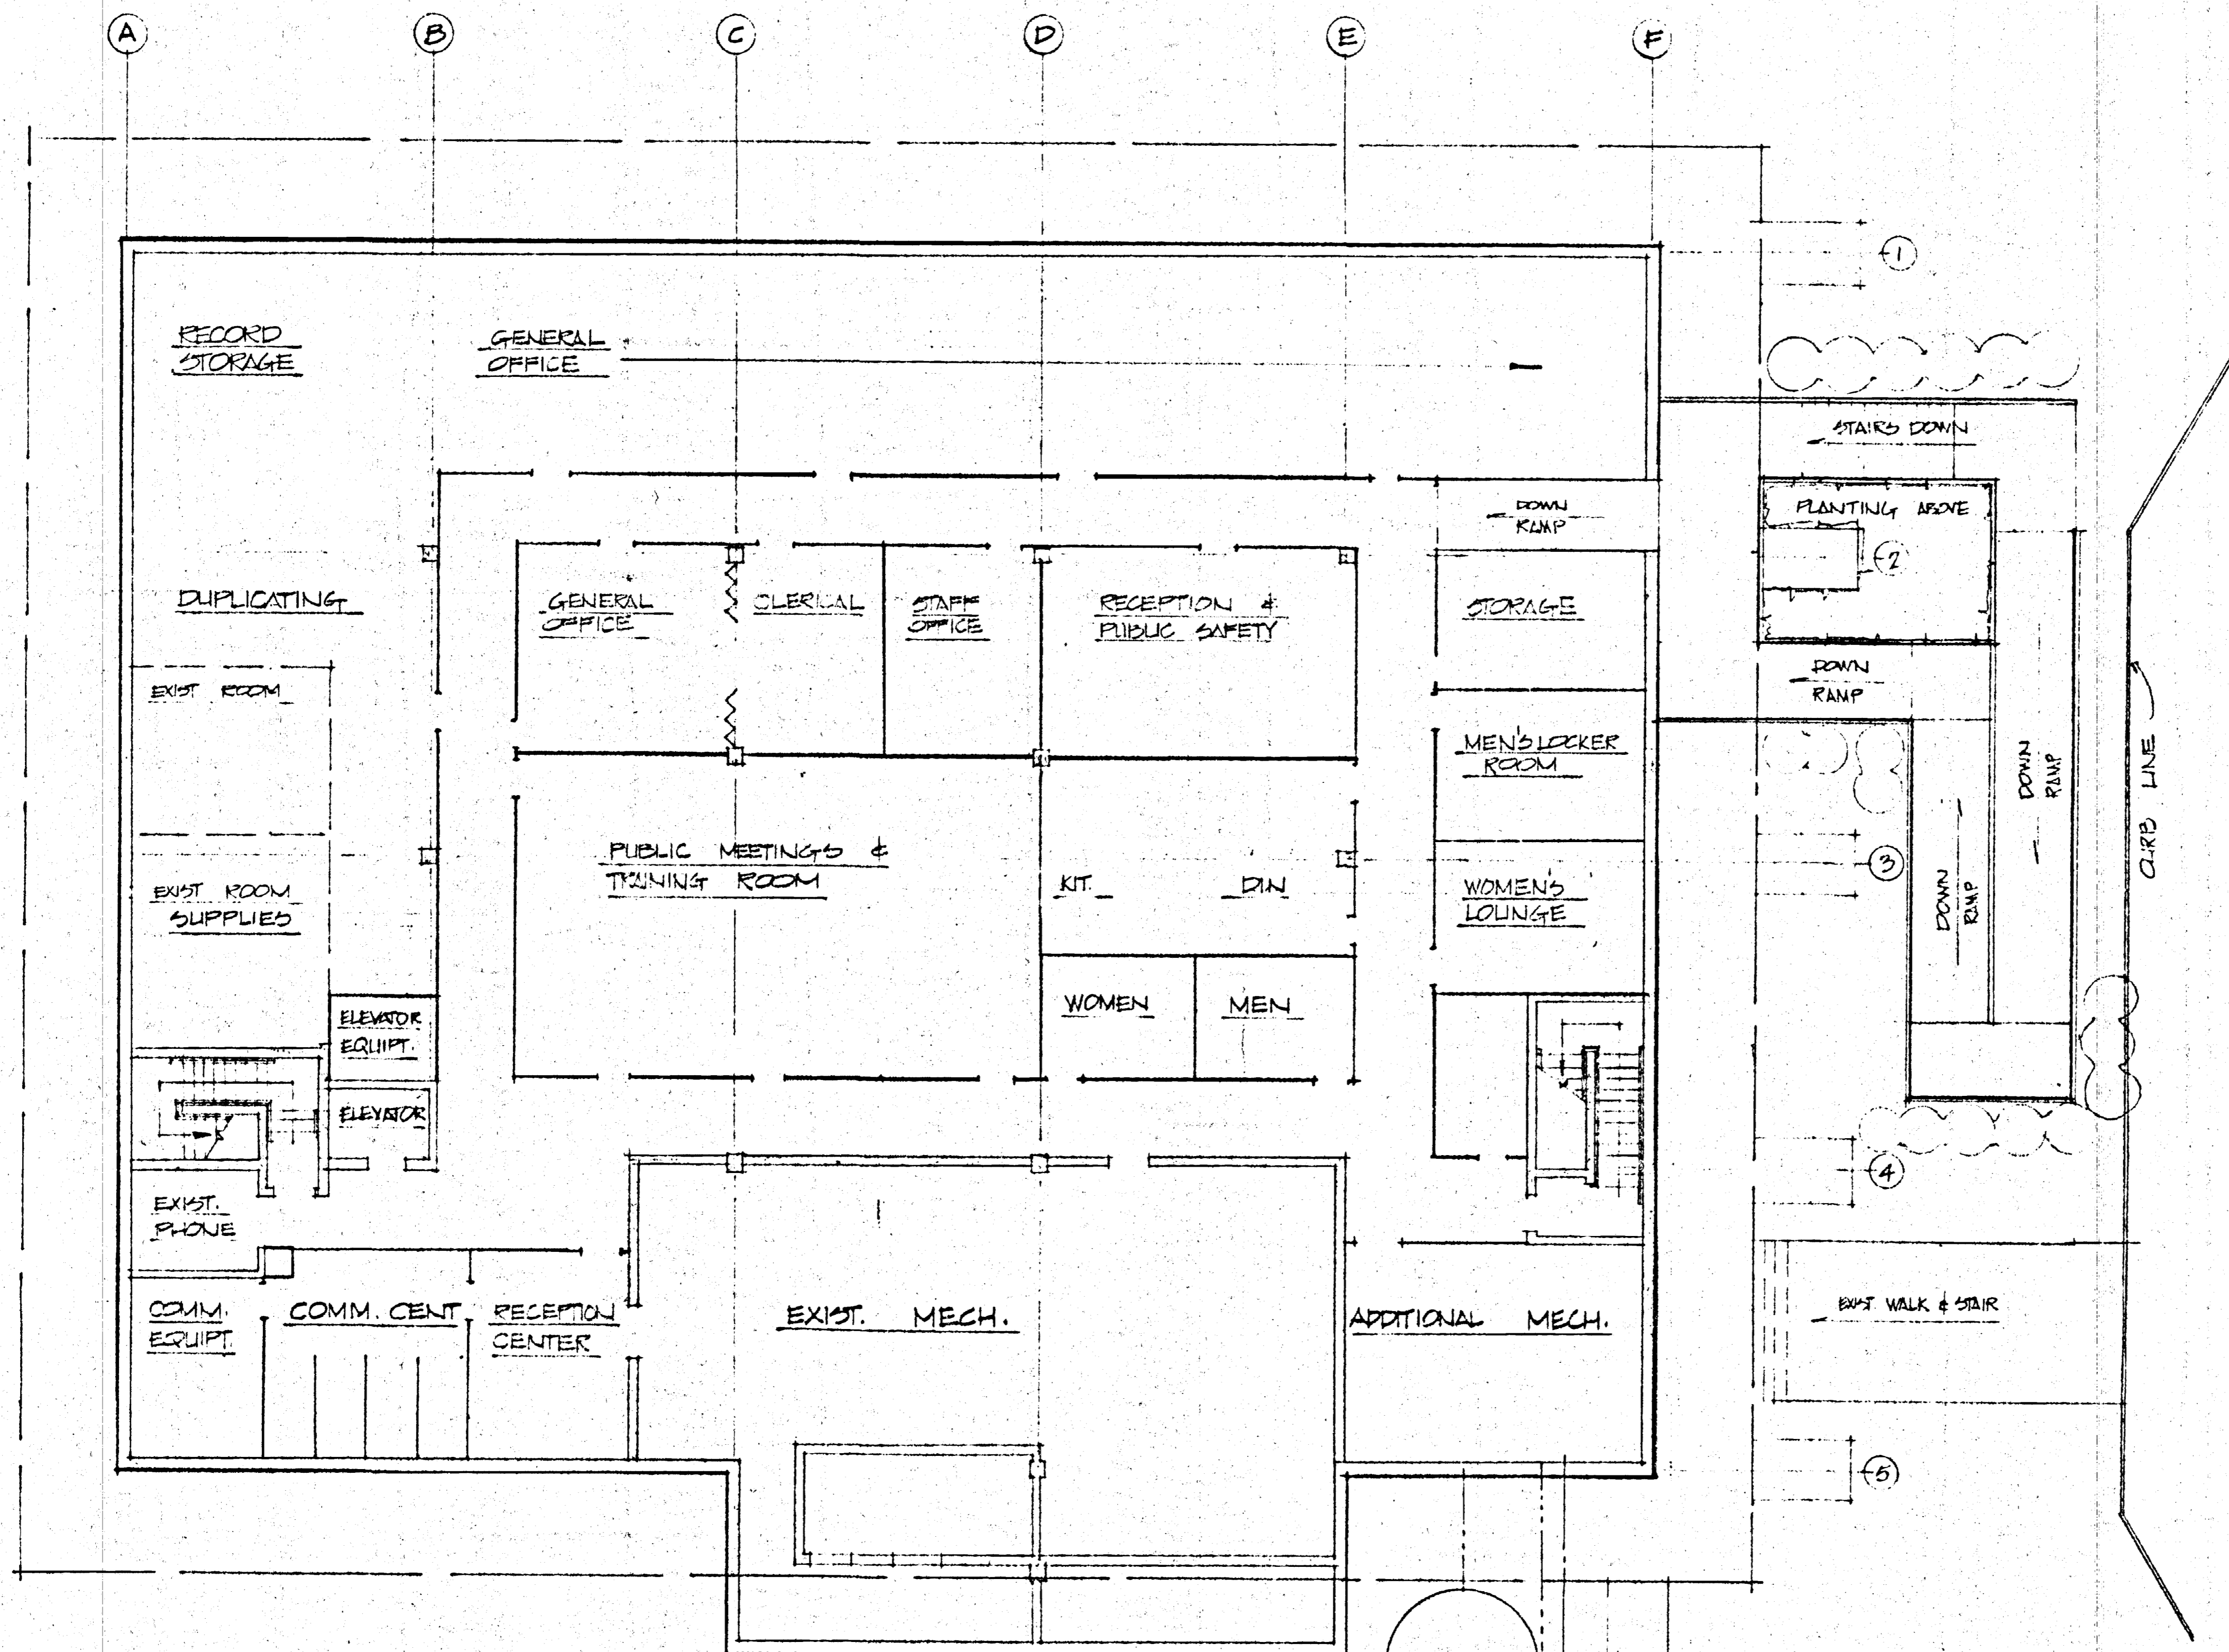


BASEMENT PLAN

5000 GAL. WATER STORAGE TANK w/ RECY. PUMP  
SEWAGE HOLDING TANK (IF POSSIBLE)  
EMERGENCY FUEL STORAGE TANK + 5000 GAL. TANK

SCALE 1/8" = 1'-0"

WILFRED E. BLESSING F.A.I.A. ARCHITECT & LANDSCAPE ARCHITECT SAN JOSE, CALIFORNIA	WILFRED E. BLESSING F.A.I.A. ARCHITECT & LANDSCAPE ARCHITECT SAN JOSE, CALIFORNIA
CUPERTINO CITY HALL	BASEMENT PLAN - GENERAL USAGE
A-2	51,045



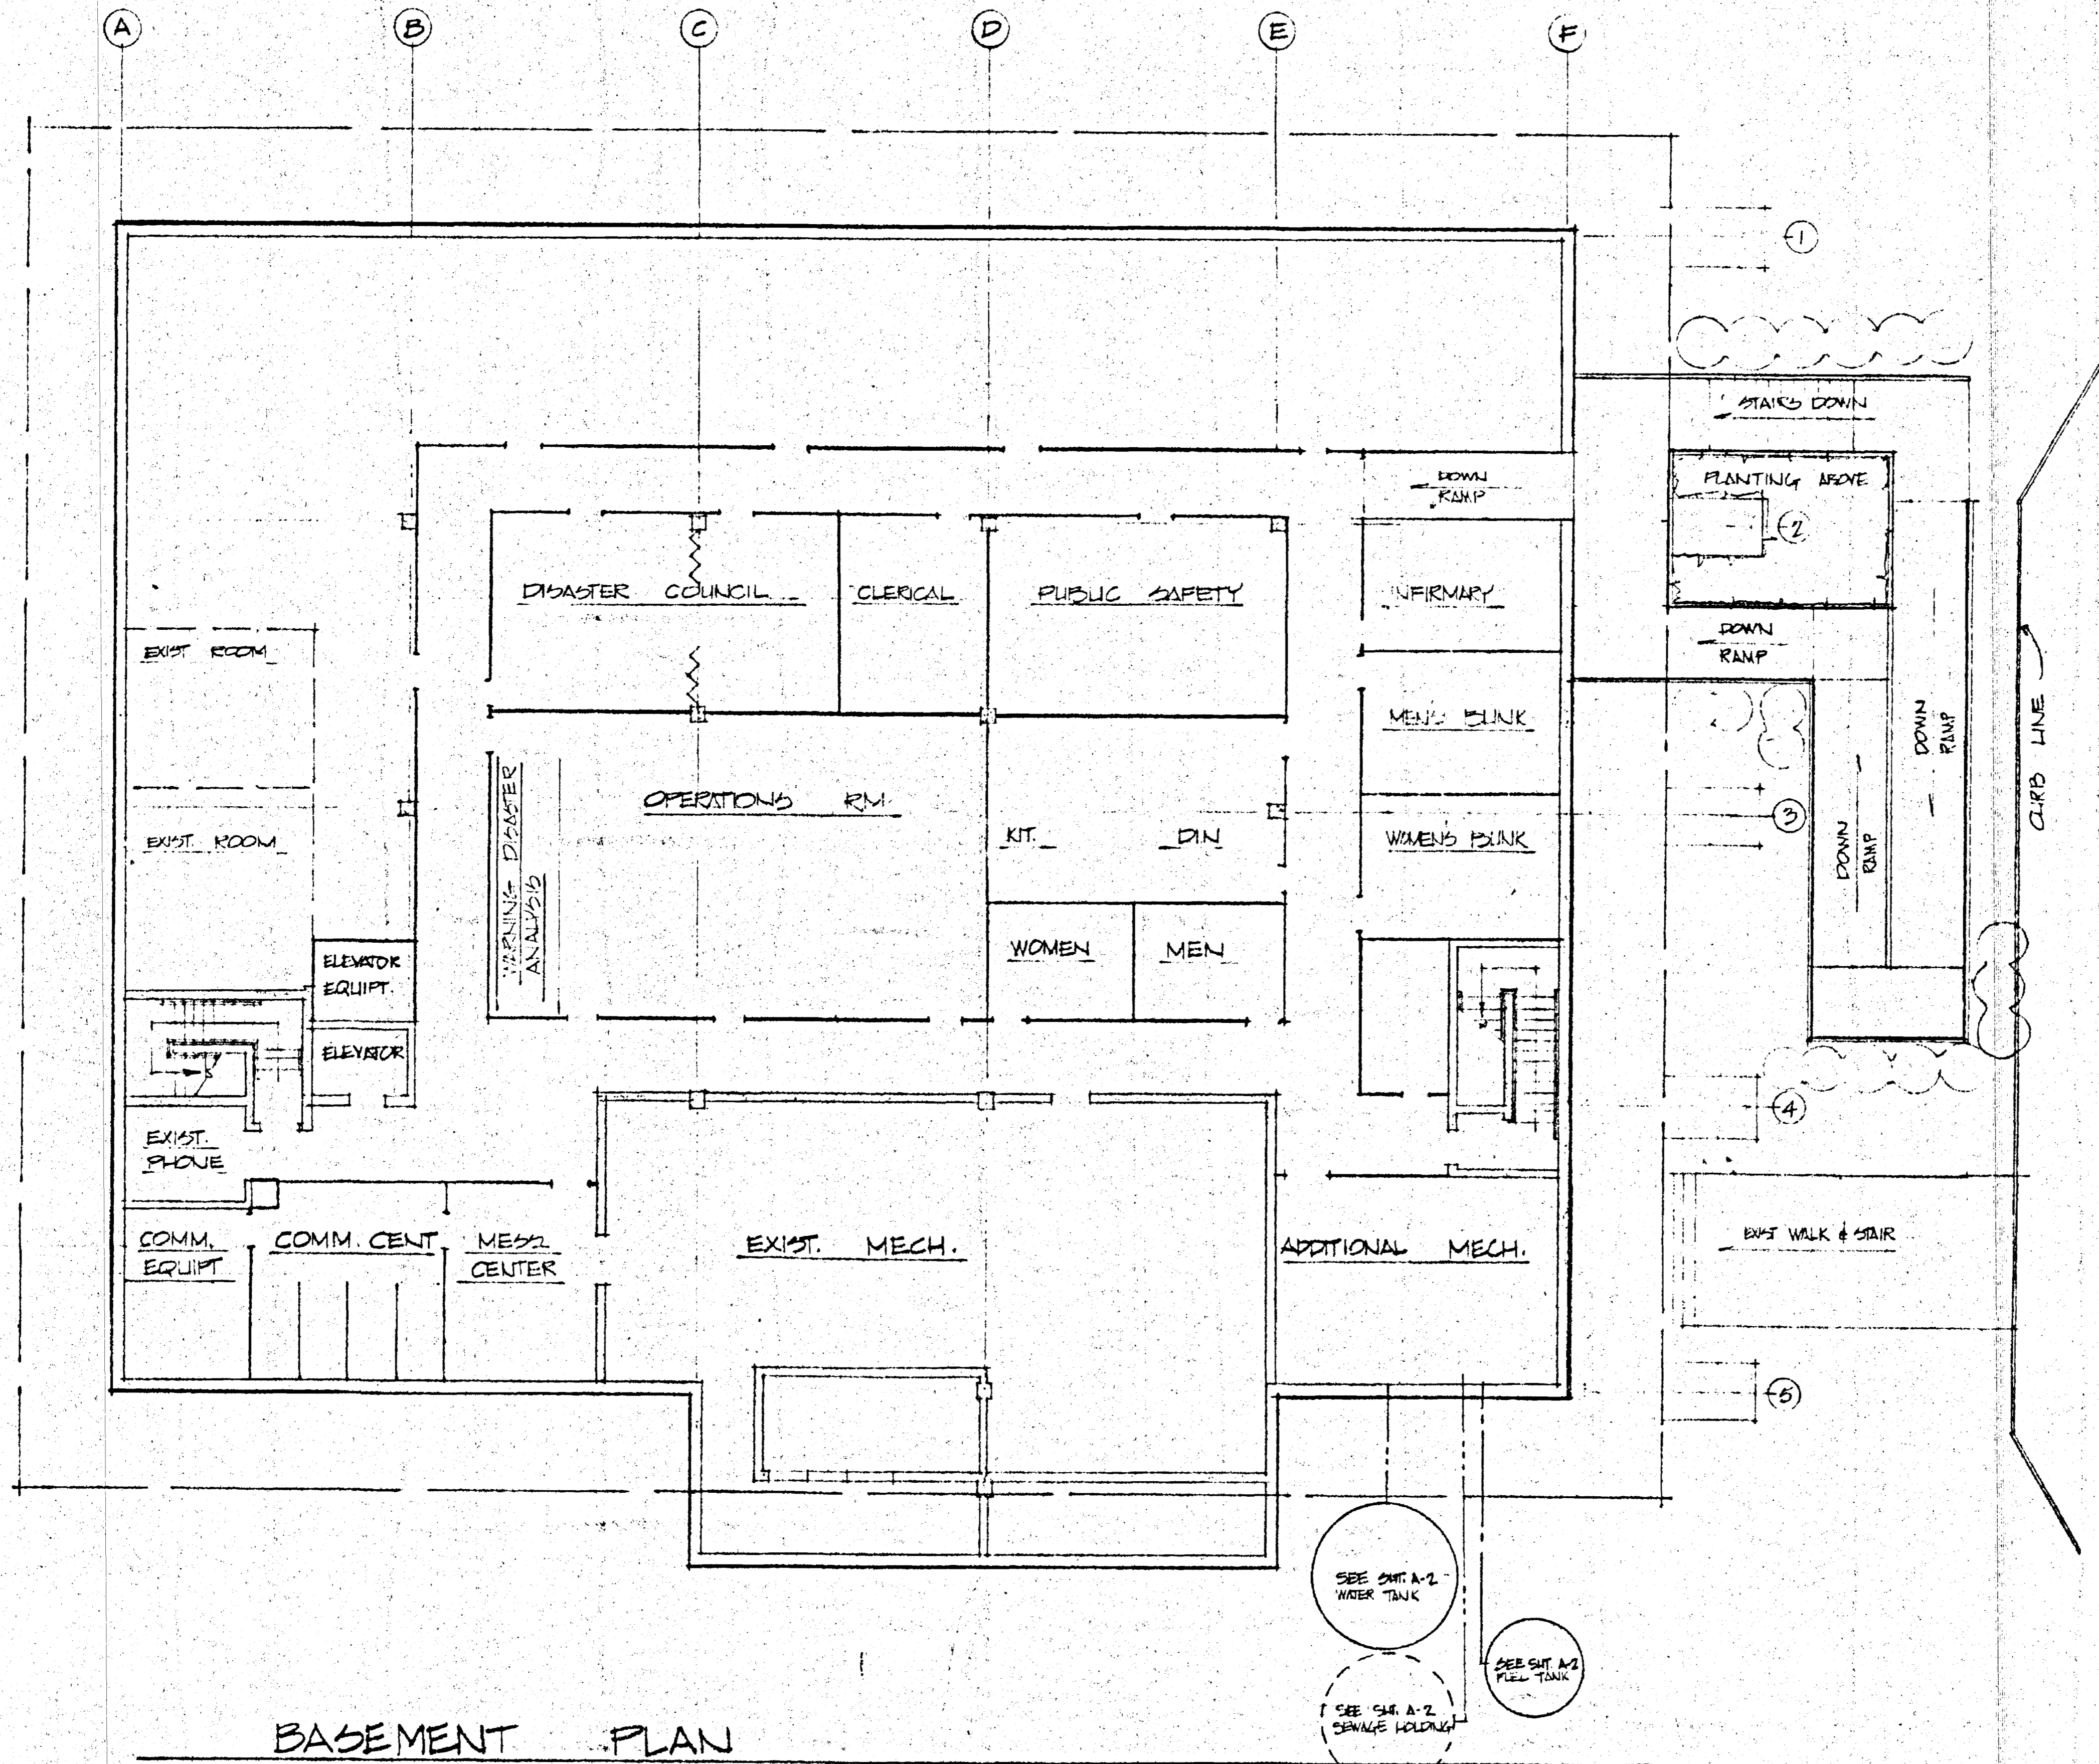

BASEMENT PLAN


SCALE 1/8" = 1'-0"

DRAWN W.F.  
CHECKED  
DATE 1-18-75  
3-5-75  
REVISIONS  
WILFRED E. BLESSING F.A.I.A.  
ARCHITECT & LANDSCAPE ARCHITECT  
SAN JOSE, CALIFORNIA

CUPERTINO CITY HALL  
BASEMENT PLAN - E.O.C. PLAN

A:3  
51,045



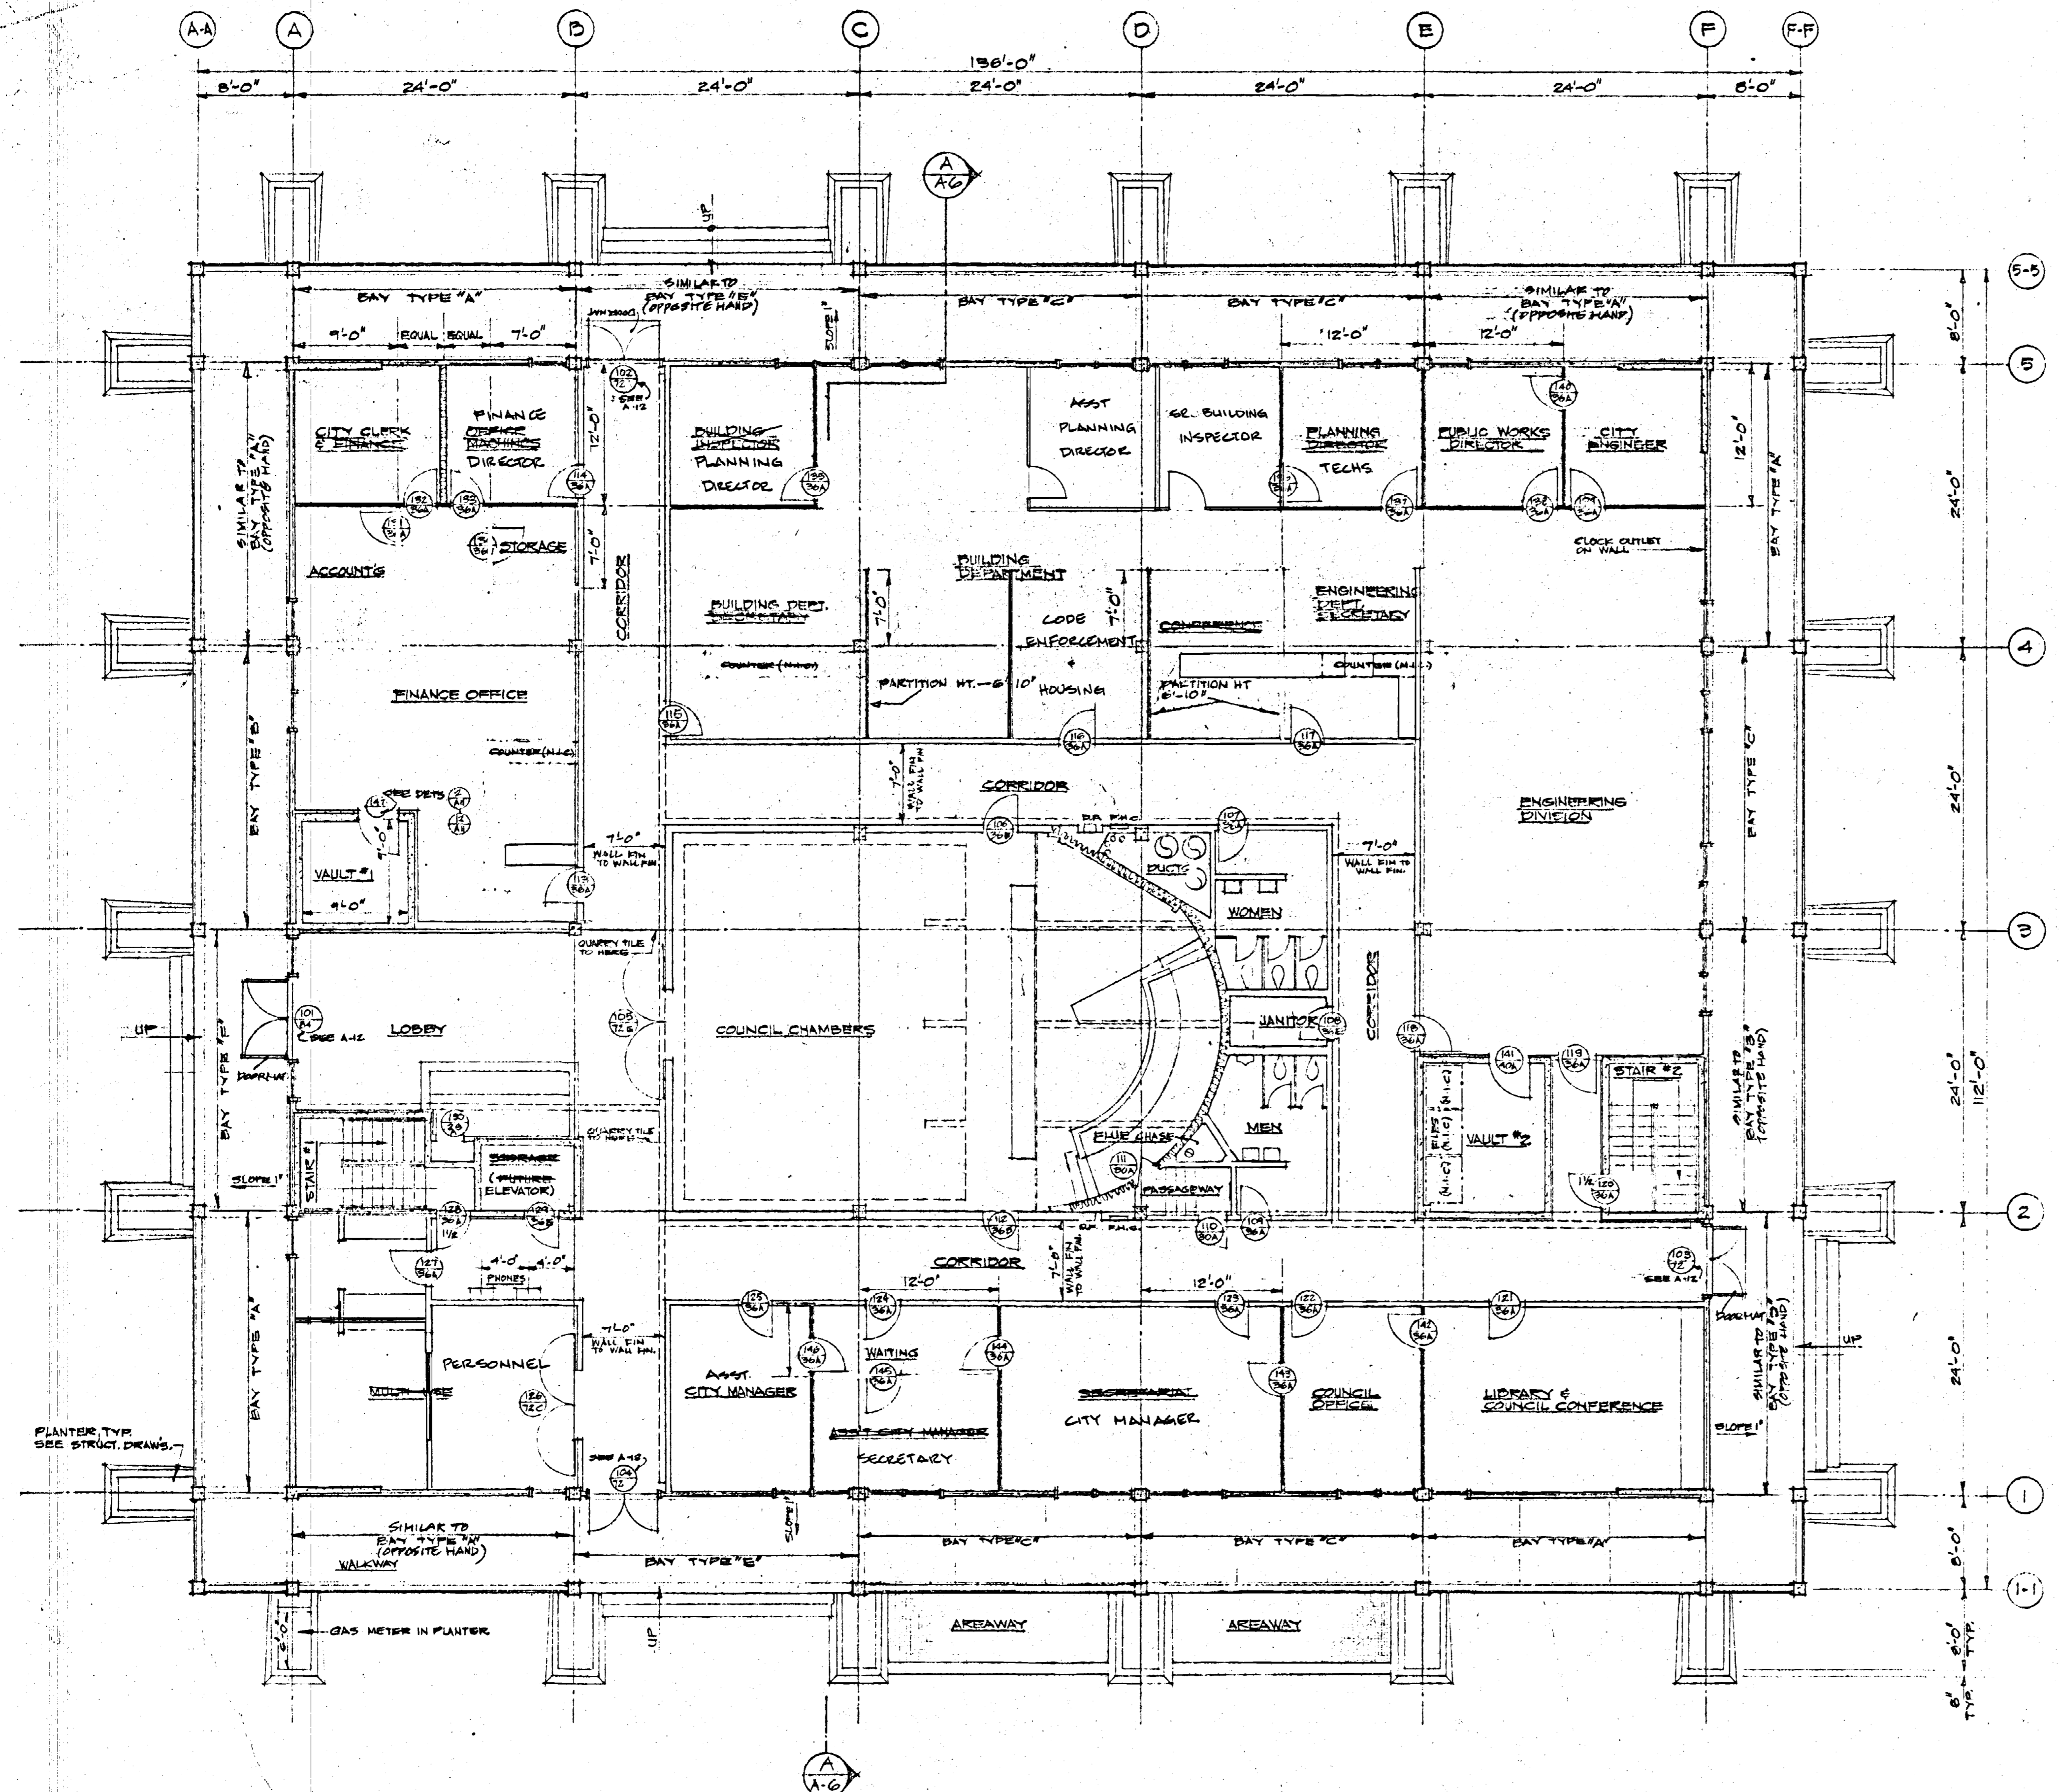

MAIN FLOOR PLAN  
SCALE: 1/8" = 1'-0"

TYPE	REMARKS	TYPE	REMARKS
A	SOLID CORE WOOD	C	SOLID CORE WOOD
B	SPECIAL JAMB FOR CLOSER	D	METAL DOOR WITH FUSIBLE LINK LOUVER, SEE A-15
		E	SOLID CORE WOOD WITH LOUVER F.D. ON DOOR 108, 129
		F	METAL DOOR

115 — DOOR NUMBER, SEE ALSO HARDWARE SCHEDULE.  
36A — DOOR TYPE, SEE ABOVE.  
1 1/2 — LABEL FOR FIRE DOORS, IN HOURS.  
DOOR WIDTH, IN INCHES, S.C.  
ALL DOORS 1 3/4" THICK

DOOR SCHEDULE

- SYMBOLS:
- [Symbol] STUD WALL
  - [Symbol] STAGGERED STUD WALL, W/ 3" INSULATION WOVEN BETWEEN STUDS
  - [Symbol] CONCRETE
  - [Symbol] MOVABLE PARTITIONS

NOTES:  
FOR EXTERIOR WALL BAY DIMENSIONS & DETAILS, SEE A-12.

ENLARGED PLANS:  
A-7 LOBBY, MULTI-USE, VAULTS & STAIRS.  
A-8 COUNCIL CHAMBERS, LIBRARY & COUNCIL CONF.  
A-16 AREAWAYS & TRANSFORMER VAULT.

PLAN SYMBOLS & NOTES

DRAWN: [Signature] CHECKED: [Signature] DATE: 02/11/55. REVISED:

WILFRED E. BLESSING A.I.A.  
ARCHITECT & LANDSCAPE ARCHITECT  
1835 THE ALAMEDA  
SAN JOSE, CALIFORNIA 95126

CUPERTINO CITY HALL  
S.E. CORNER OF RODRIGUES & TORRE, CUPERTINO, CALIFORNIA

MAIN FLOOR PLAN.

[Signature]

CITY HALL MAIN FLOOR PLAN 51, 045