




PARTIAL ROOF PLAN  
SCALE: 1/4" = 1'-0"

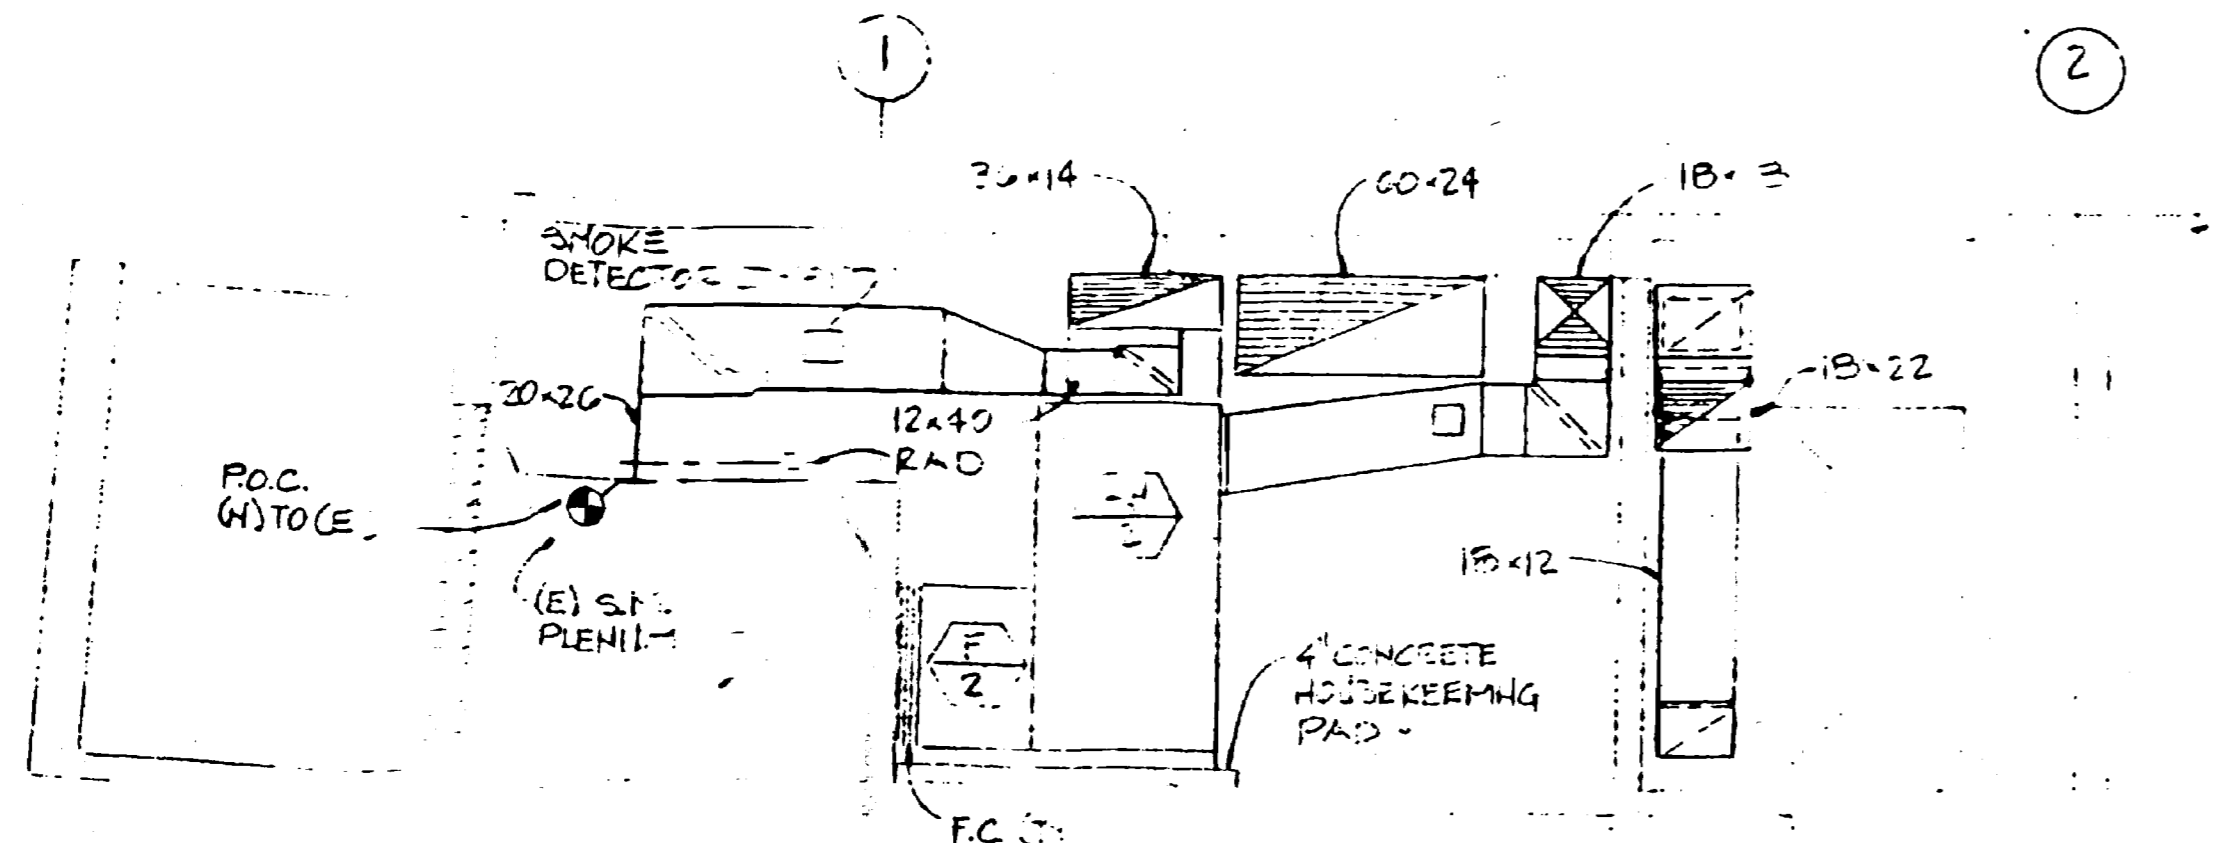


SECTION  
SCALE: 1/4" = 1'-0"

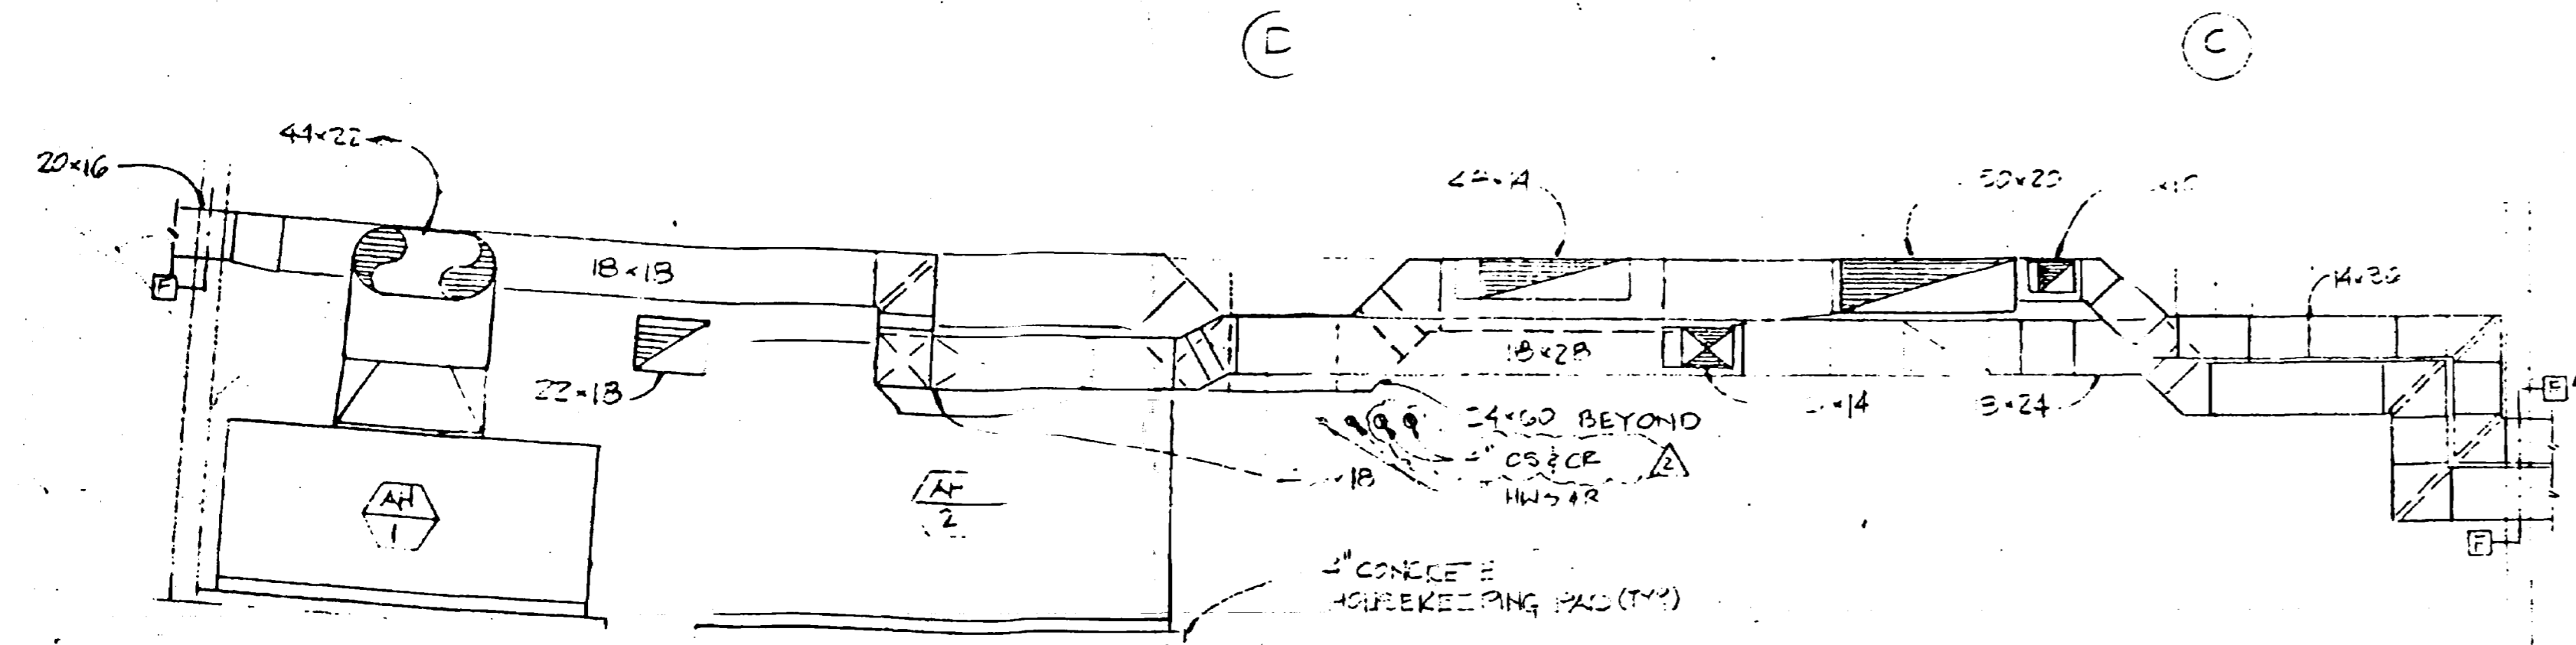

SECTION  
SCALE: 1/4" = 1'-0"

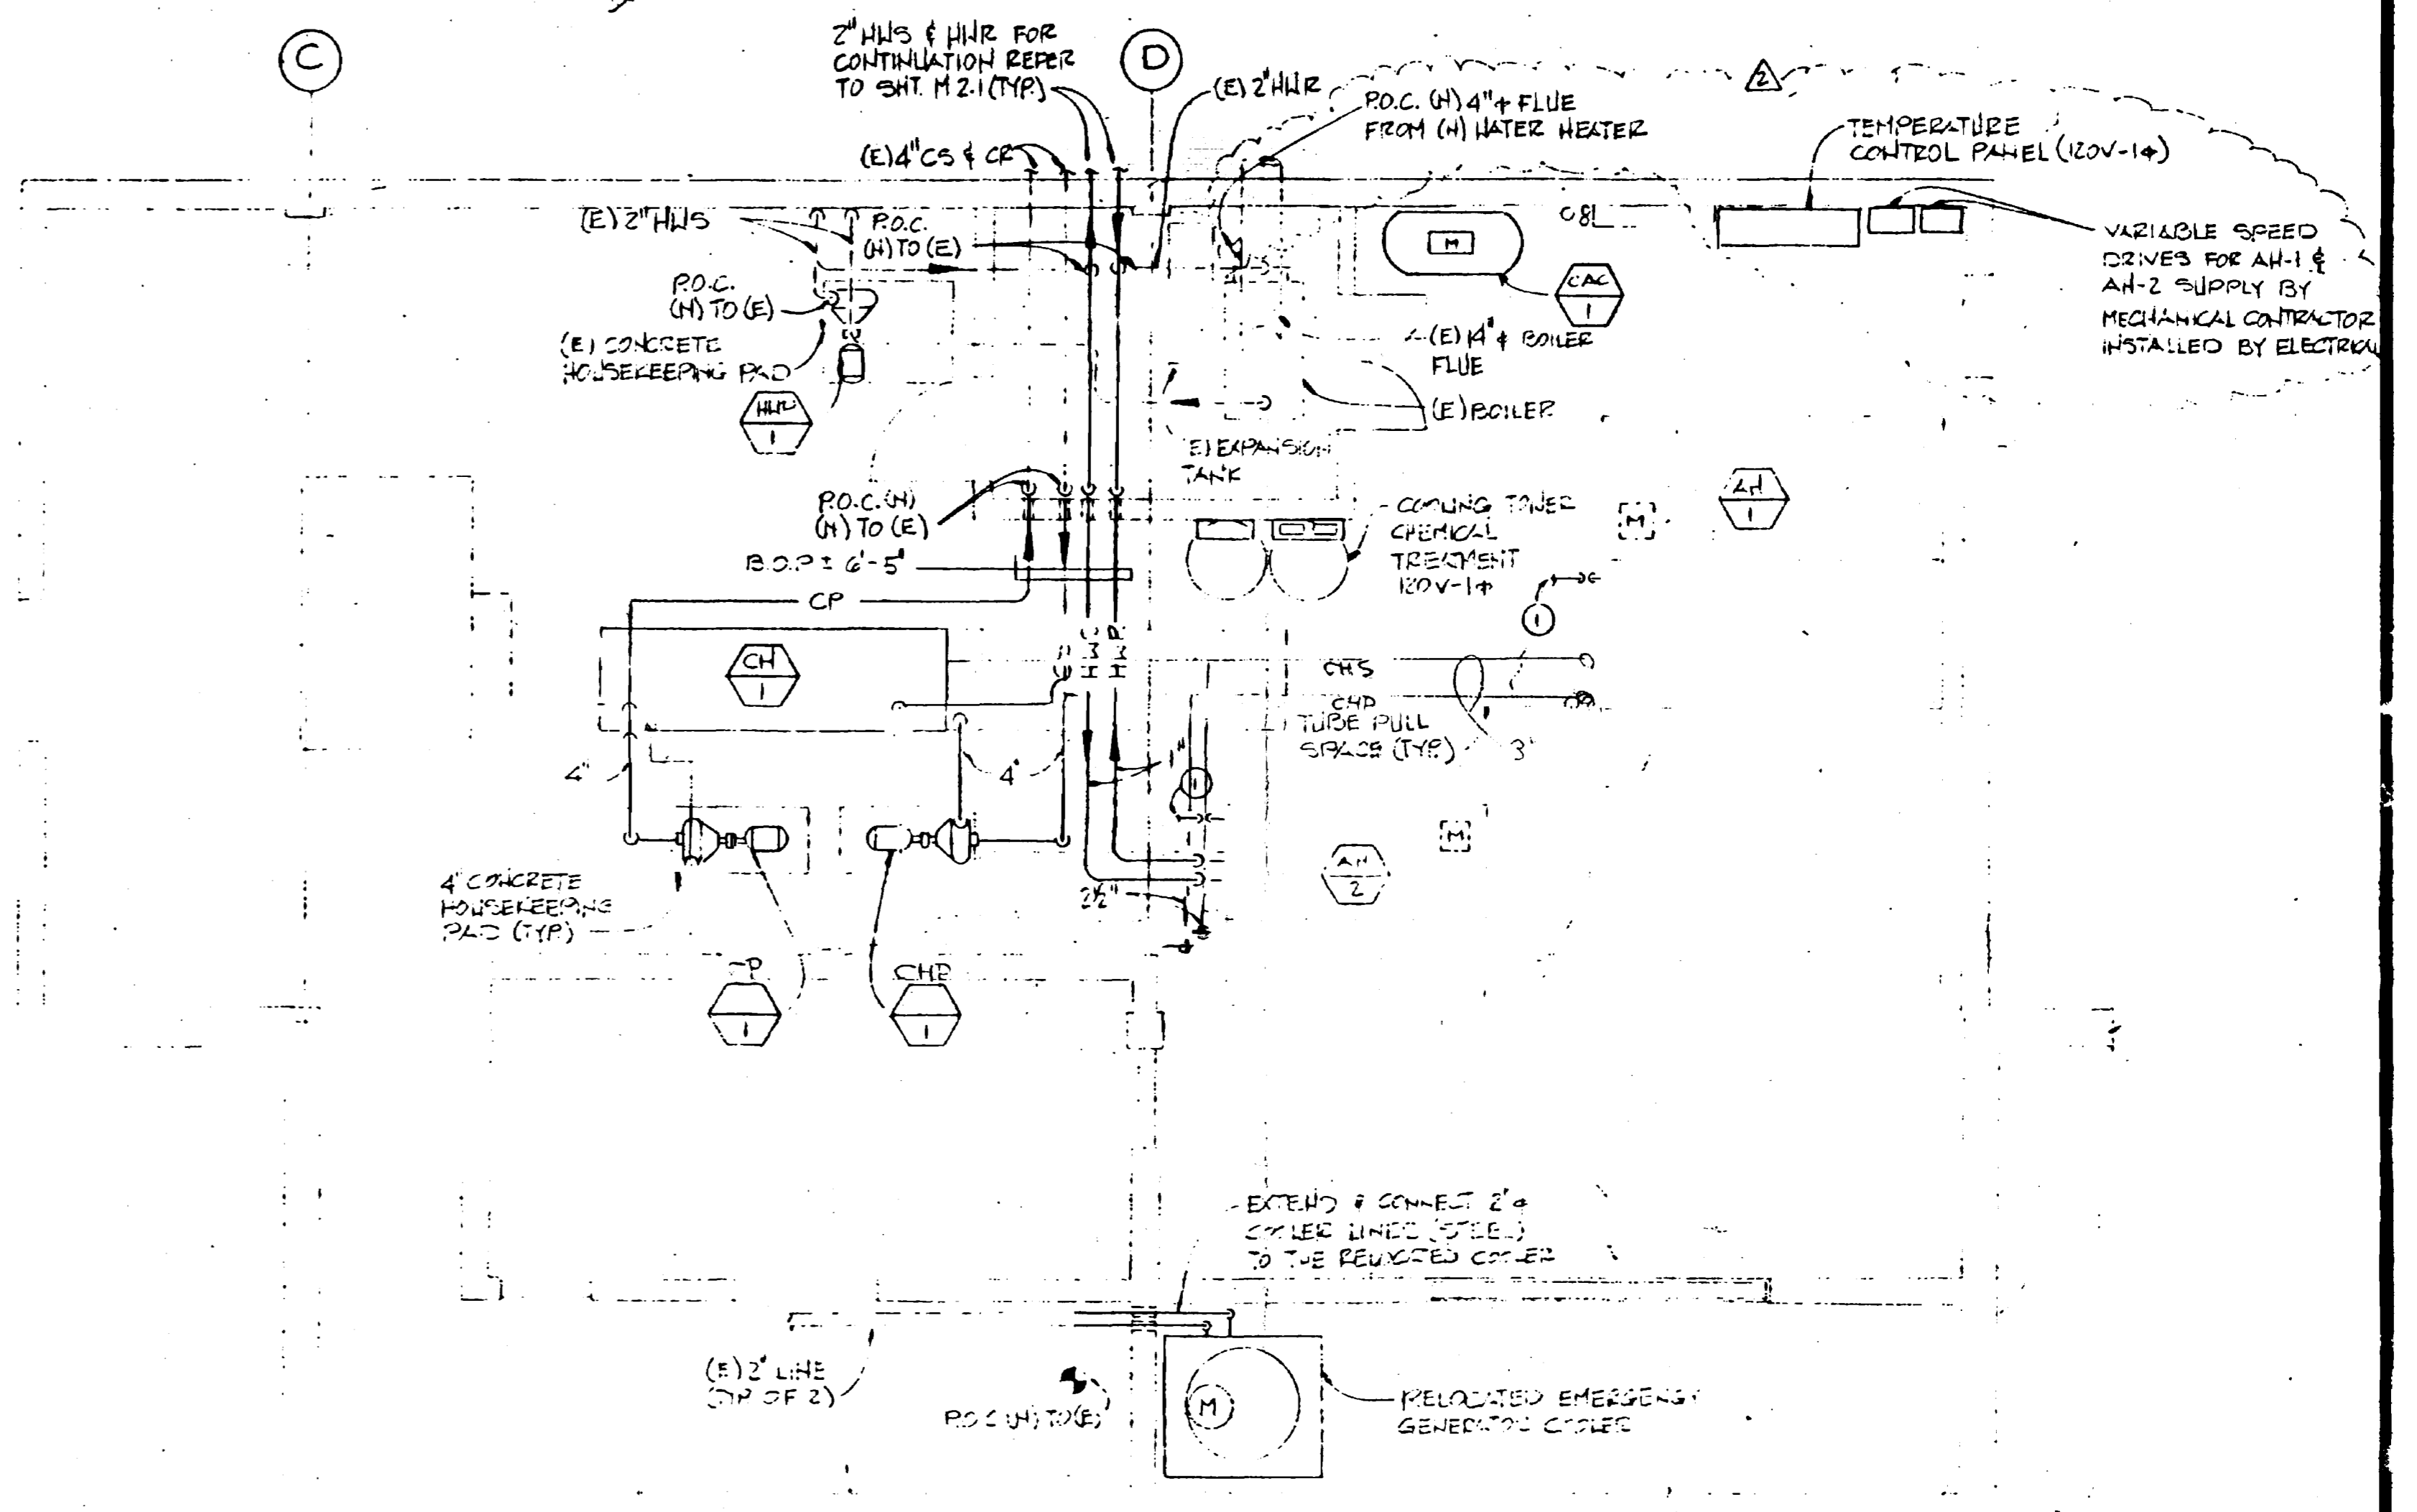

MECHANICAL RM PLAN  
SCALE: 1/4" = 1'-0"

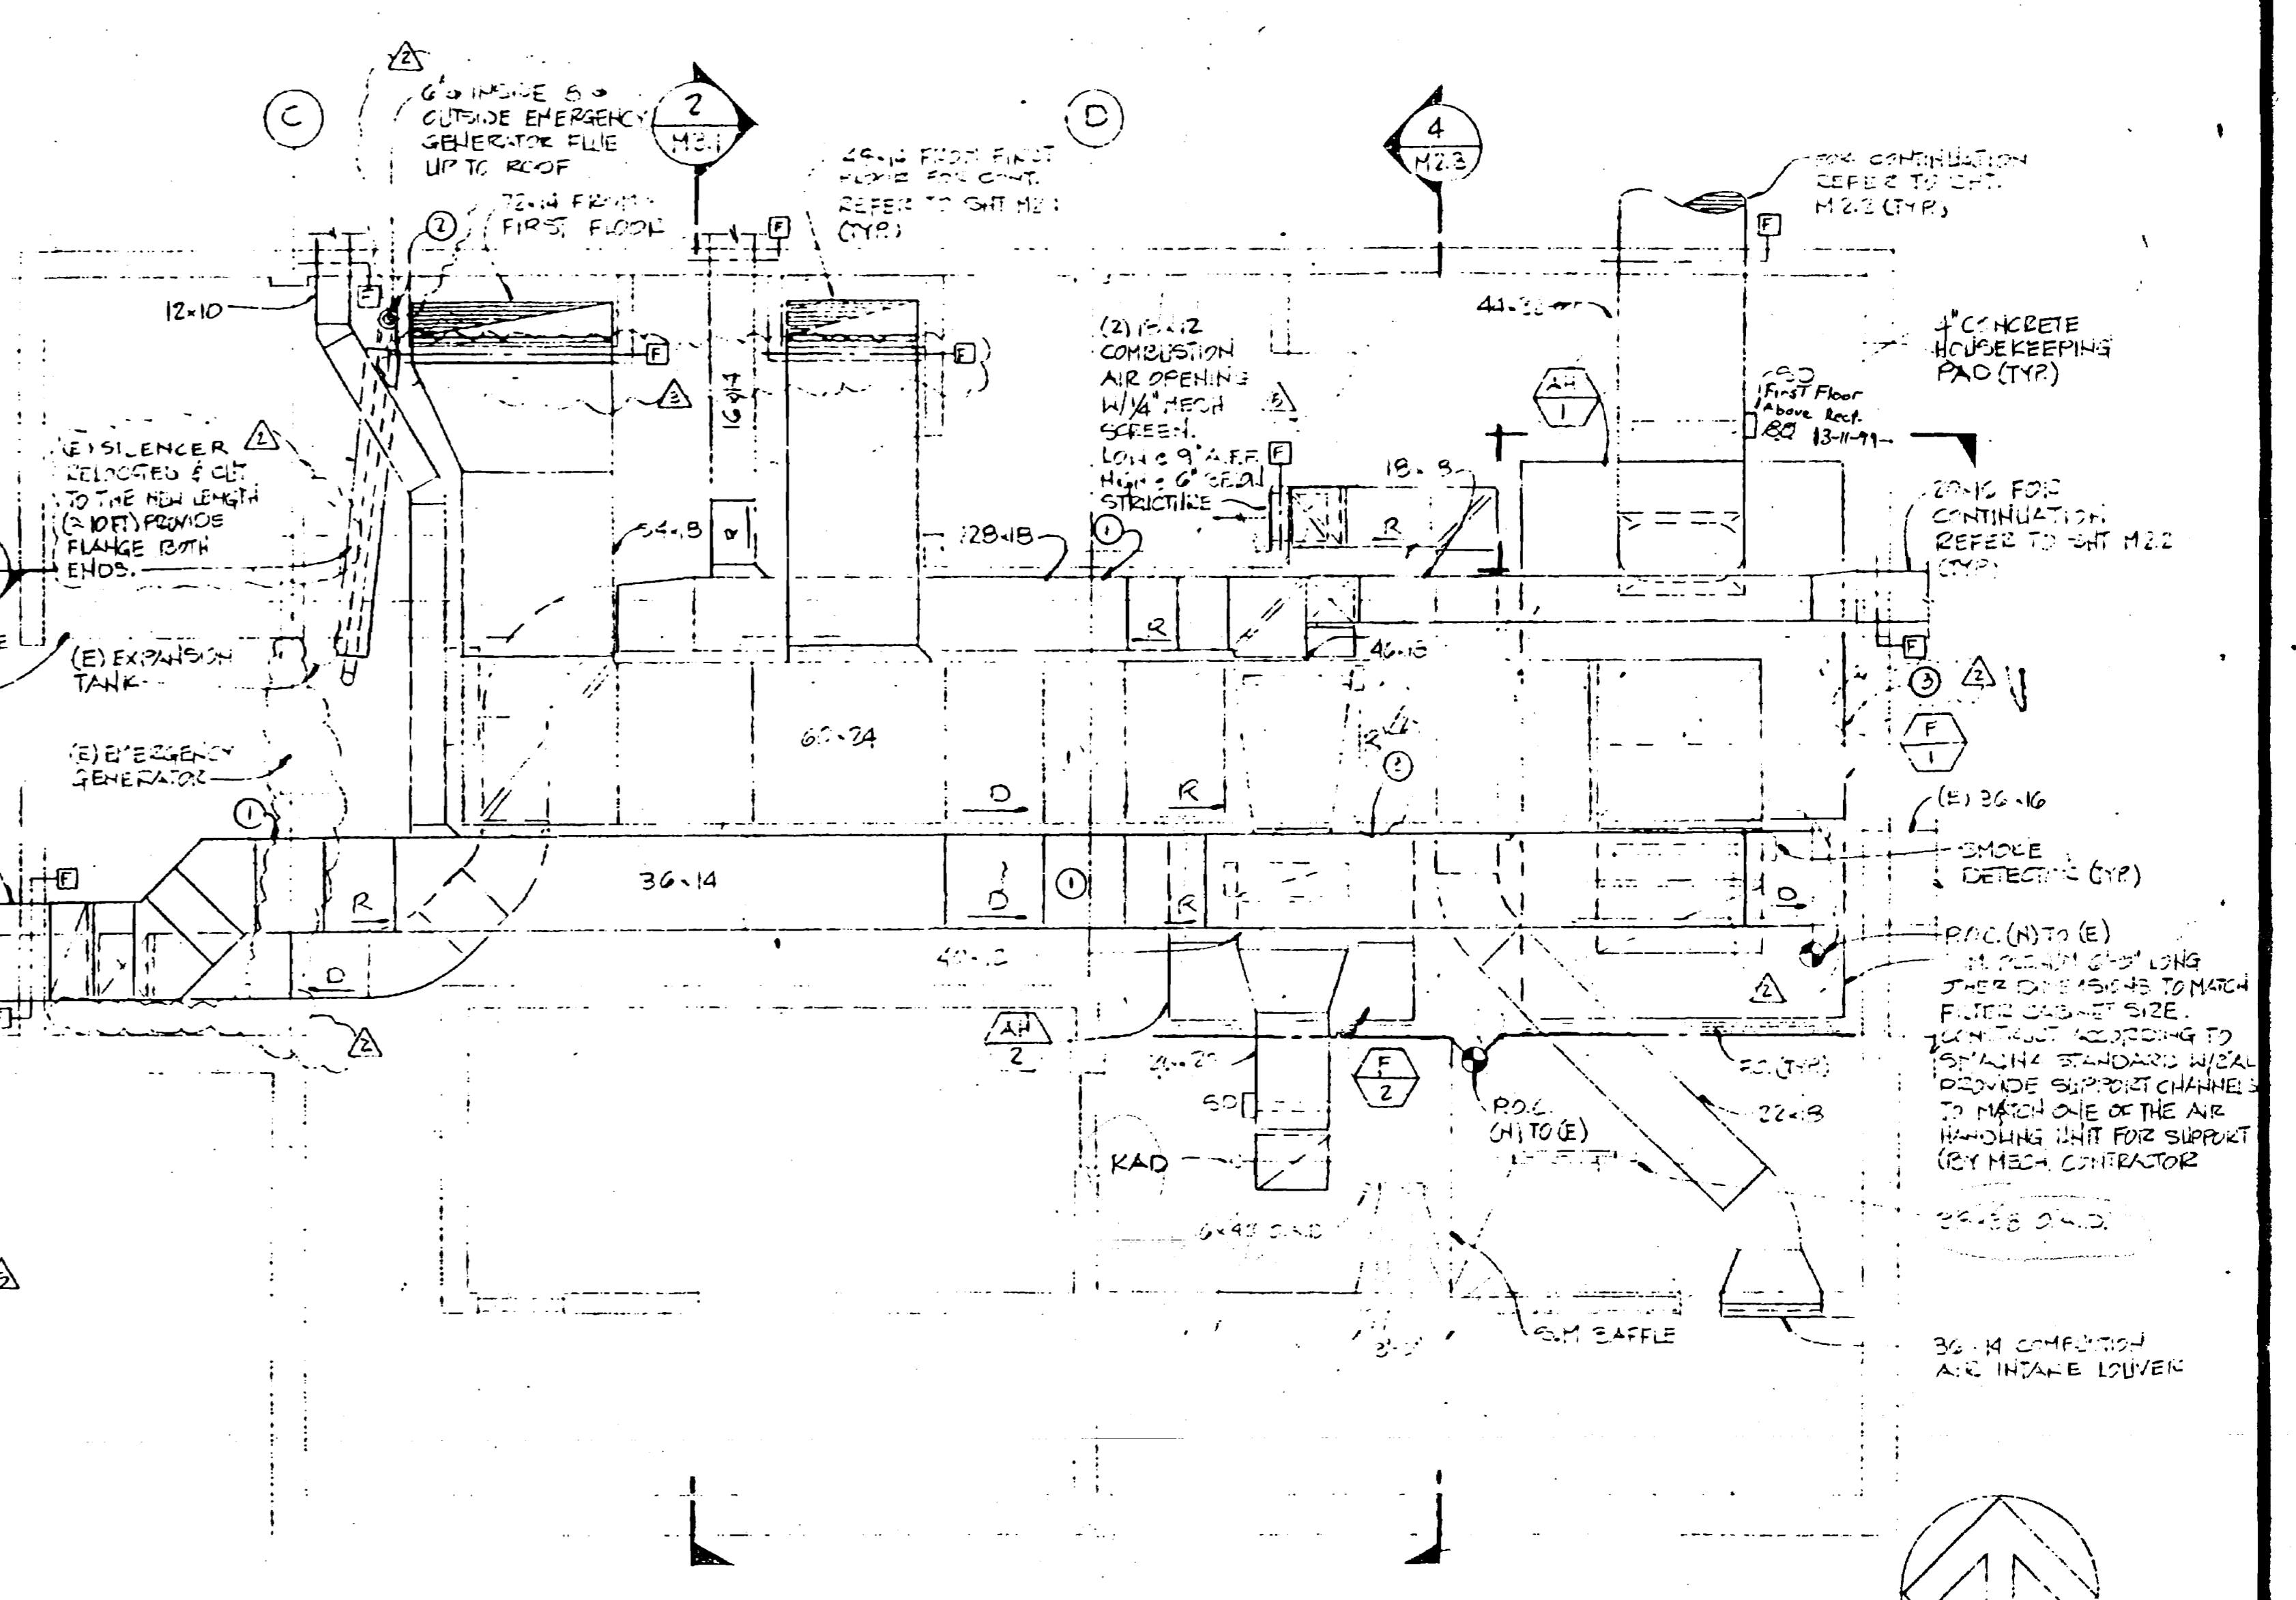

MECHANICAL RM PLAN  
SCALE: 1/4" = 1'-0"

- NOTES:
- 1 DUCT TIGHT TO THE BOTTOM OF BEAM
  - 2 (H) EMERGENCY GENERATOR FLEW SHALL BE METALBELT'S MODEL FS, 304'SS INNER LINER, ALUMINIZED STEEL OUTER JACKET. PROVIDE ALL THE REQUIRED FITTINGS, SUPPORTS, EXPANSION JOINTS, ETC.
  - 3 BOLT DOWN AIR HANDLING UNITS TO CONCRETE CURS 1/1/2" (S) 3/4" CONCRETE ANCHOR BOLTS, 2" MIN. EMBEDMENT

REVISIONS
10-25-86
11-18-86
11-21-86
12-18-86

EDITION ASSOCIATES  
1000 CALIFORNIA STREET  
SAN FRANCISCO, CA 94109  
(415) 441-1331

Civic Center Improvements  
**CITY OF CUPERTINO**  
Cupertino, California

CITY HALL  
MECHANICAL  
PARTIAL FLOOR PLANS & SECTIONS

DRAWN
CHECKED
DATE 10-10-86
SCALE AS NOTED
JOB NO.
SHEET

**M2.3**